

ADDENDUM No. 02

DATE: March 21, 2022

PROJECT: C22-01 SAVANNAH ARTS ACADEMY ADDITION & RENOVATION
SAVANNAH-CHATHAM COUNTY PUBLIC SCHOOL SYSTEM, SAVANNAH, GA

BY: COGDELL & MENDRALA ARCHITECTS, PC (Architect)
517 East Congress Street
Savannah, GA 31401

This Addendum forms a part of the Contract Documents and modifies the original Drawings and Project Manual dated February 2022 and identified as (GMP Documents).

I. GENERAL INFORMATION:

A. Not applicable for Addendum No. 02.

II. SUBSTITUTION REQUESTS:

A. Not applicable for Addendum No. 02.

III. RFI RESPONSE:

A. Not applicable for Addendum No. 02.

IV. PROJECT MANUAL:

A. Not applicable for Addendum No. 02.


V. Drawings:

A. Vol I - RENOVATION:

1. Mechanical:

a. M1.25 – MECHANICAL PLAN – MECHANICAL ROOM: Replace this sheet entirely.

END OF ADDENDUM No. 02

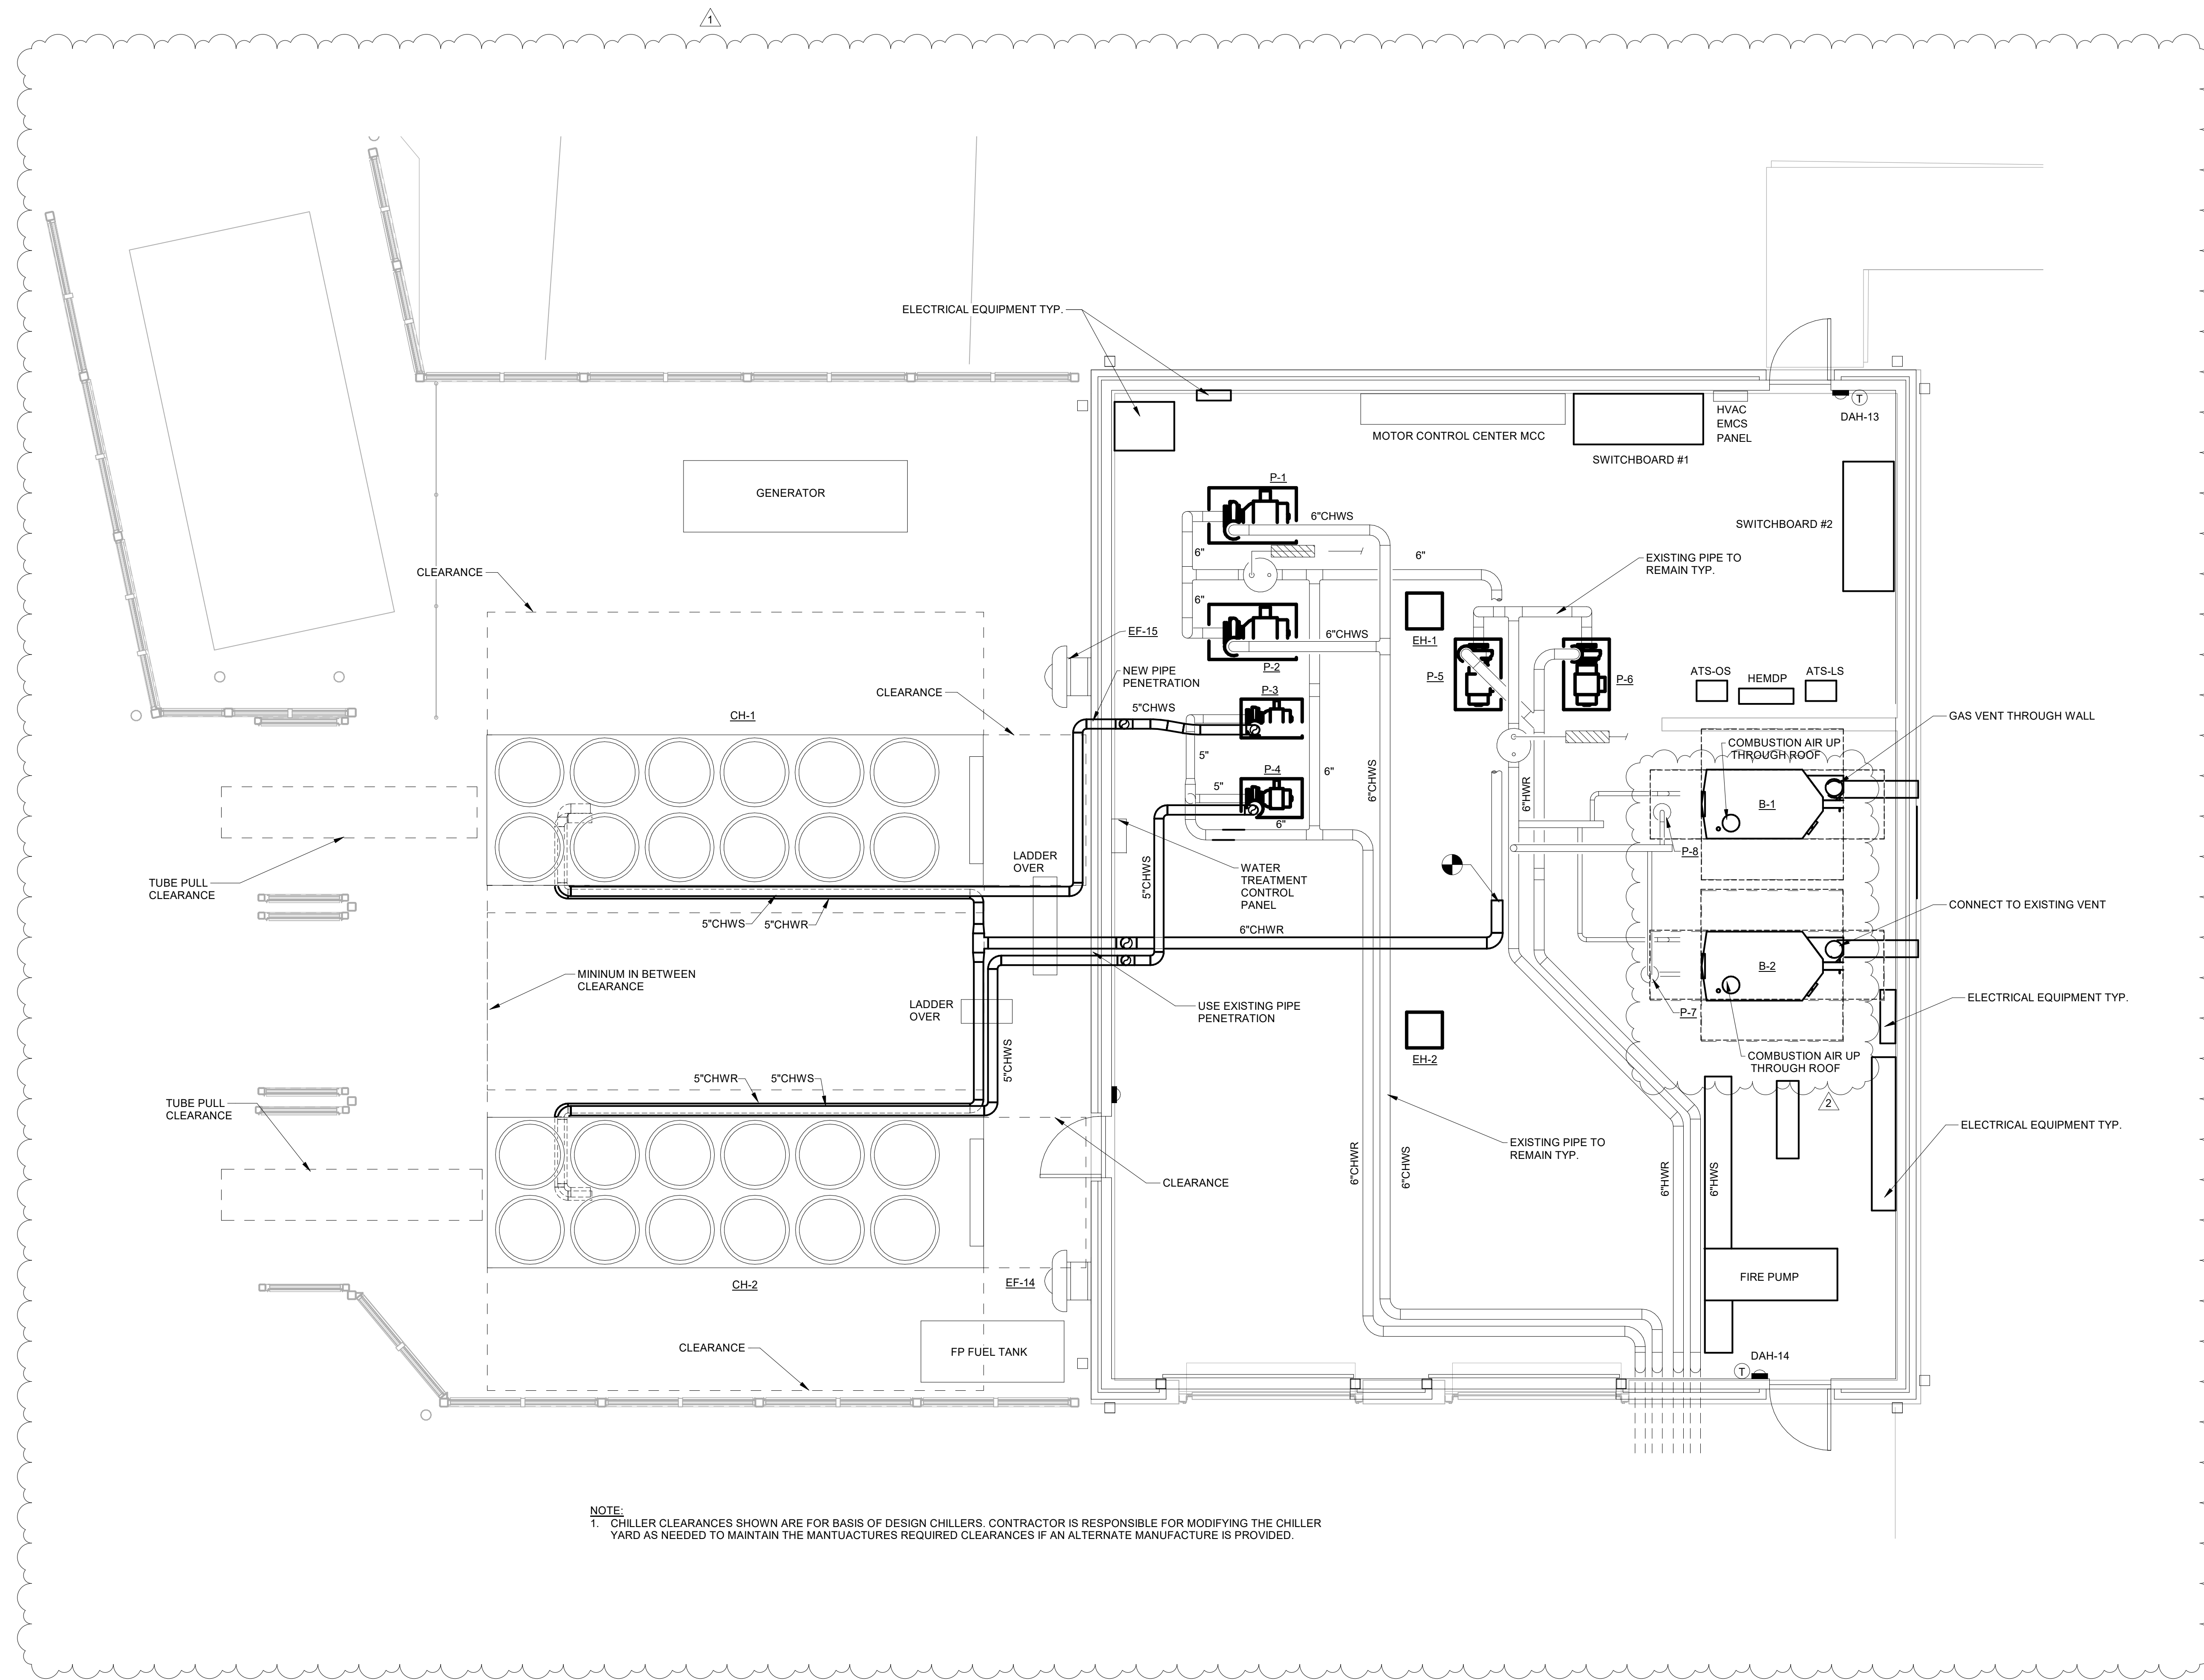


NOTE:
 1. CHILLER CLEARANCES SHOWN ARE FOR BASIS OF DESIGN CHILLERS. CONTRACTOR IS RESPONSIBLE FOR MODIFYING THE CHILLER YARD AS NEEDED TO MAINTAIN THE MANUFACTURERS REQUIRED CLEARANCES IF AN ALTERNATE MANUFACTURE IS PROVIDED.



FACILITY CODE: 1607
FTE: 1000
FUNDING: LOCAL EFFORT
BID NO#: C22-01

Cogdell Mendrala Architects
 COGDELL & MENDRALA ARCHITECTS, PC
 517 EAST CONGRESS STREET
 SAVANNAH, GEORGIA 31401
 tel 912.234.6318
 fax 912.236.8414
 cogdellmendrala.com

SEAL:

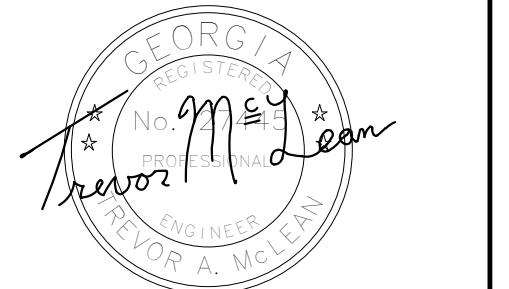


PROJECT CONSULTANTS:

CIVIL ENGINEER
MAXWELL-REDDICK & ASSOCIATES
 40 JOE KENNEDY BLVD.
 STATESBORO, GA 30458

STRUCTURAL ENGINEER:
SAUSSY ENGINEERING
 400 E. JOHNNY MERCER BOULEVARD
 SAVANNAH, GA 31410

MECHANICAL & ELECTRICAL ENGINEER:
DULOHERY WEEKS ENGINEERS
 7402 HODGSON MEMORIAL DRIVE,
 SUITE 100
 SAVANNAH, GA 31406

KEY PLAN:

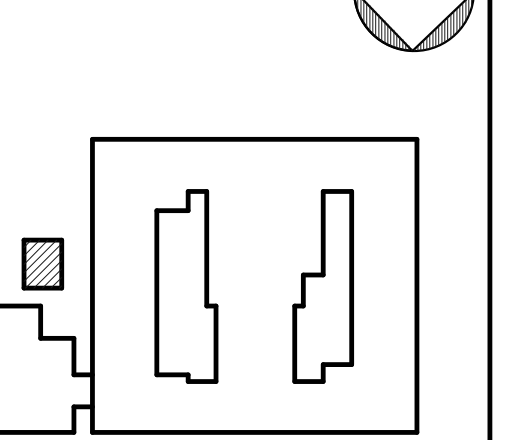

SHEET TITLE:
MECHANICAL PLAN - MECHANICAL ROOM

REVISION SCHEDULE	
DATE	DESCRIPTION
03/14/22	ADDENDUM #1
03/21/22	ADDENDUM #2

PROJECT NO: 1916
DATE: FEB 2022
DRAWN BY: JML
SCALE: 1/4" = 1'-0"
SHEET: **M1.25**

